


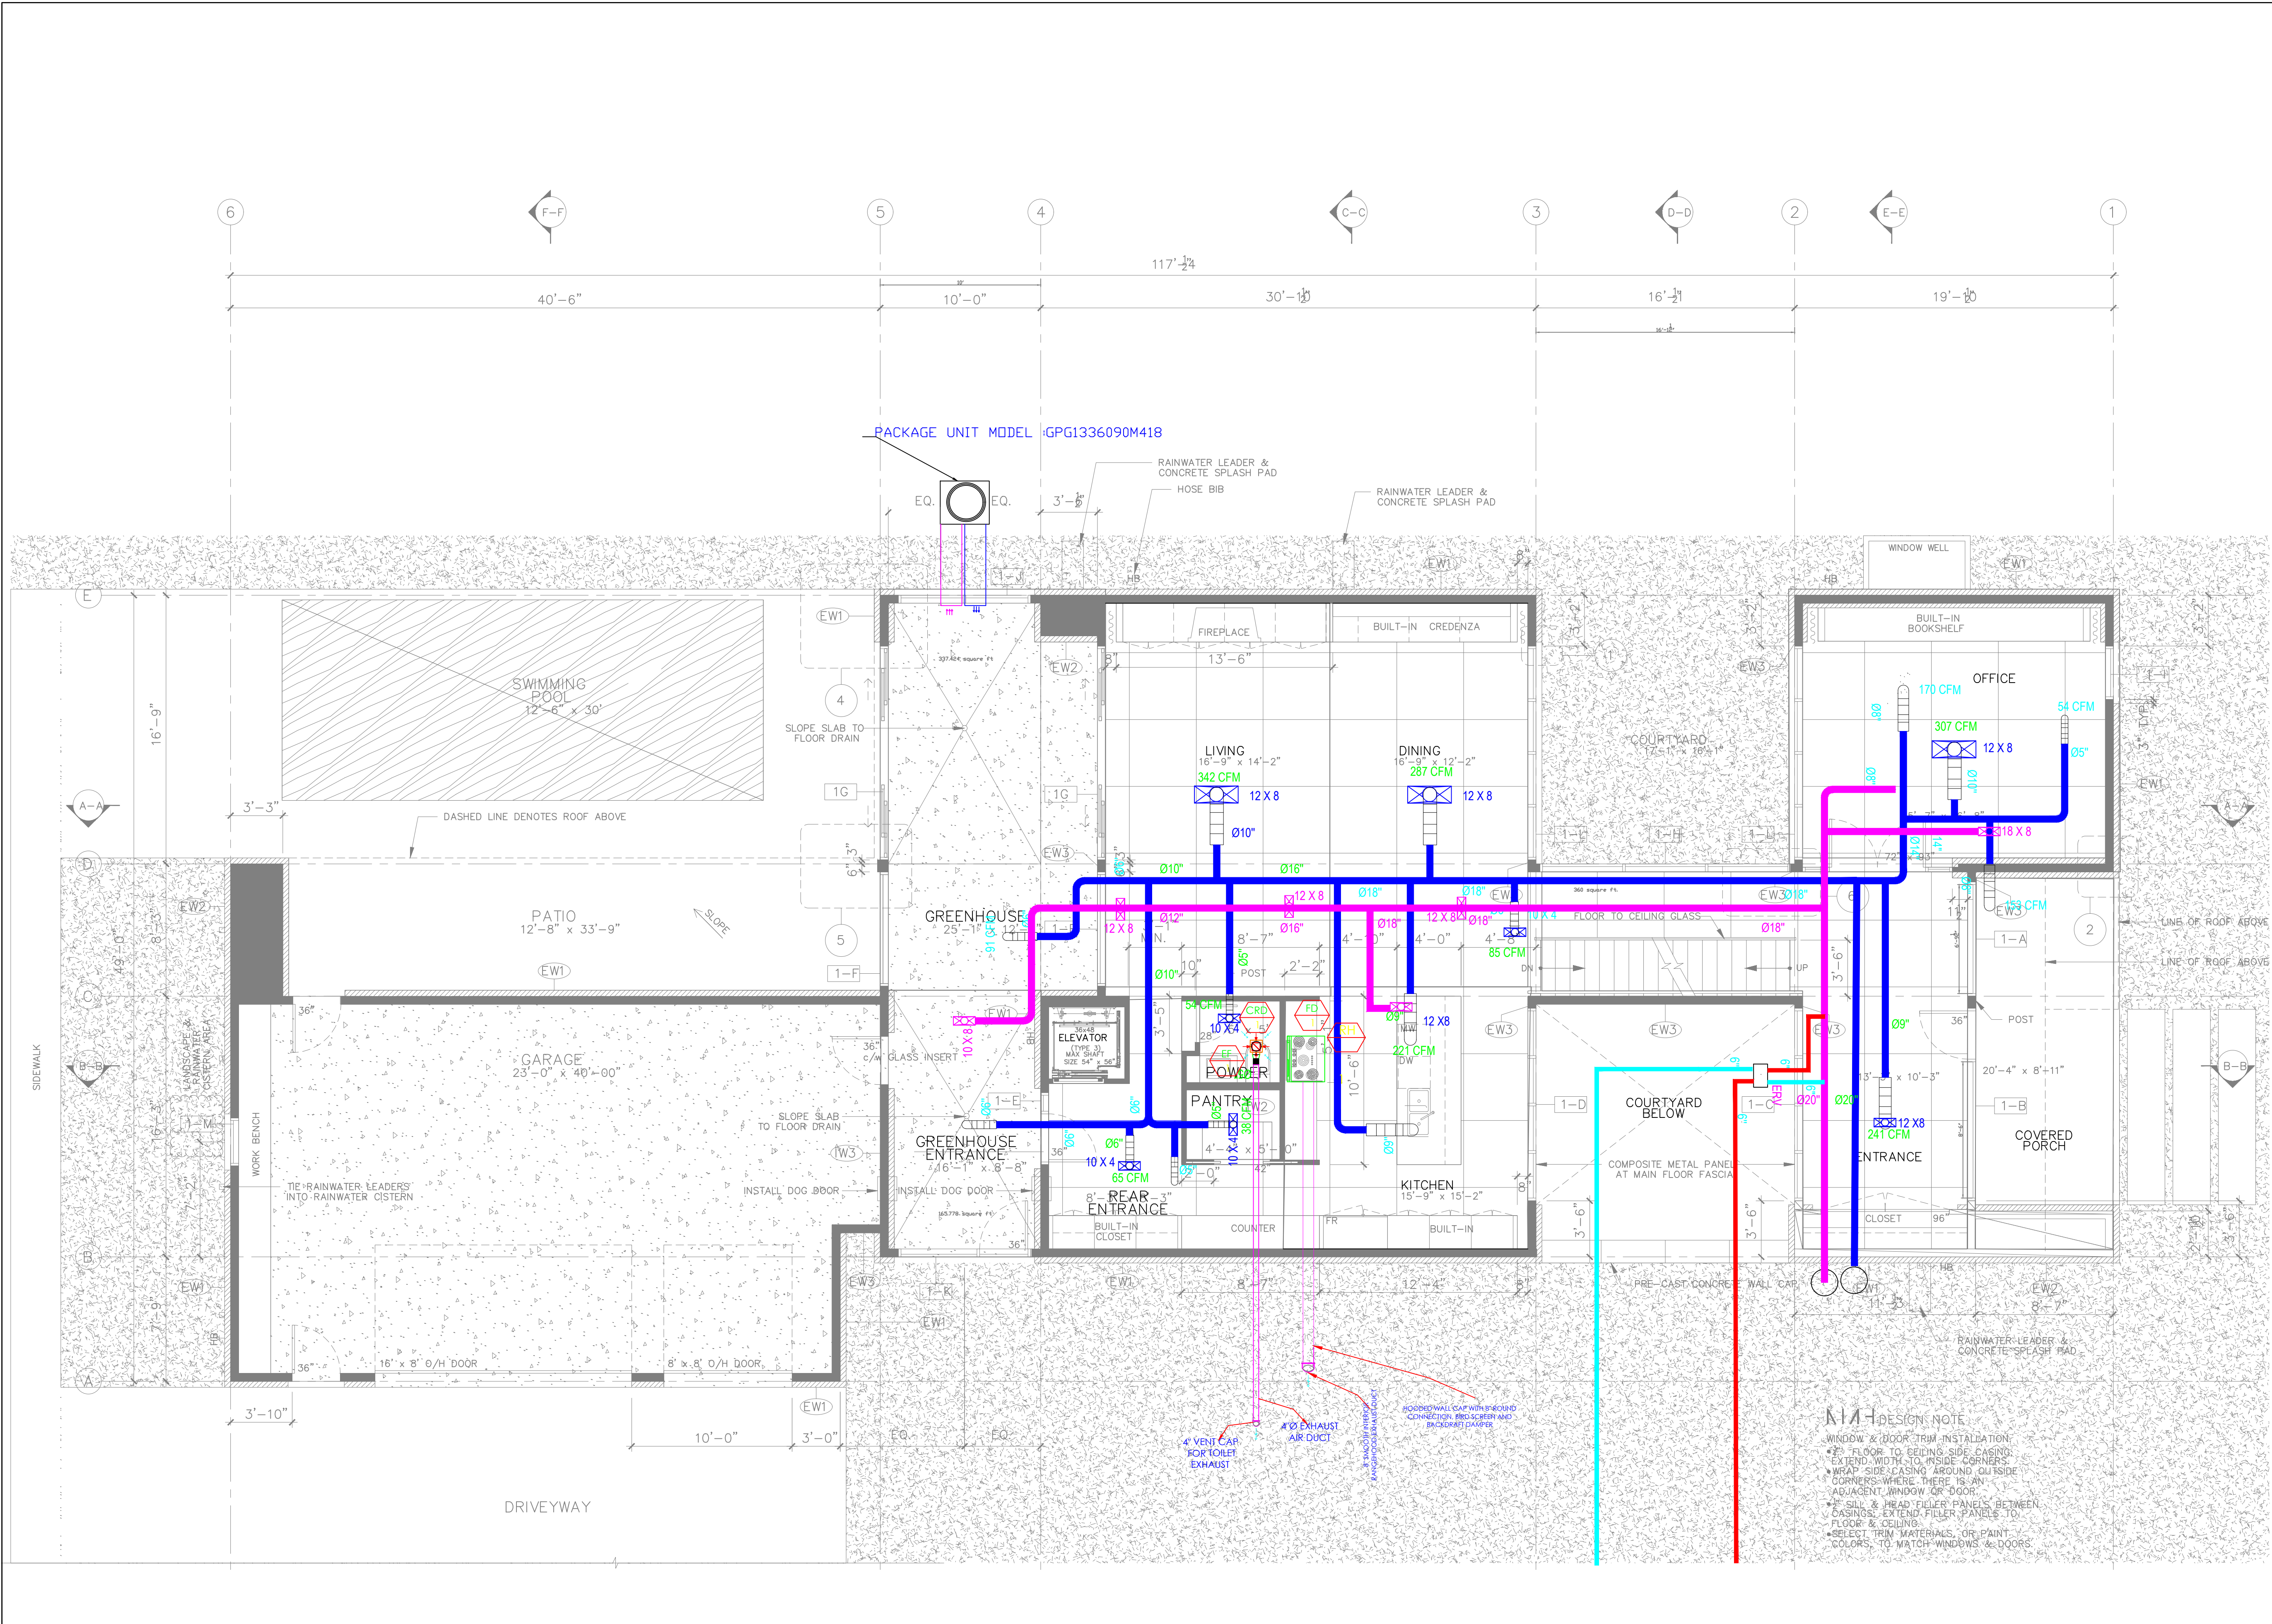

MARTIN RESIDENCE

499 Jay Windom
Martin Residence
6406 Westover
Dr. Granbury, TX.

REVISIONS

DATE ISSUED: 10. 13.2025

PROJECT NUMBER
P22077

SHEET TITLE

MAIN FLOOR HVAC PLAN

SHEET NUMBER
M-02